



FIXTURE DESCRIPTION	
(P)	COOPER GALLEON GLEON-SM4B-730-U-5W0-BZ, 171W TYPE 5 DISTRIBUTION, FIBERGLASS POLE 48'-6" ABOVE GRADE, WITH 2'-6" BASE.
(P1)	COOPER GALLEON GLEON-SA3B-730-U-SL4-HSS-BZ, 124W TYPE 4 DISTRIBUTION, FIBERGLASS POLE 48'-6" ABOVE GRADE, WITH 2'-6" BASE.
(W)	LITHONIA DSXW2 LED 30K 30C 530 T2M, 54W LED, 20' MOUNTING HEIGHT.
(W1)	LITHONIA DSXW2 LED 30K 30C 530 T4M, 54W LED, 20' MOUNTING HEIGHT.
(W2)	LITHONIA DSXW2 LED 30K 20C 530 T4M, 36W LED, 20' MOUNTING HEIGHT.

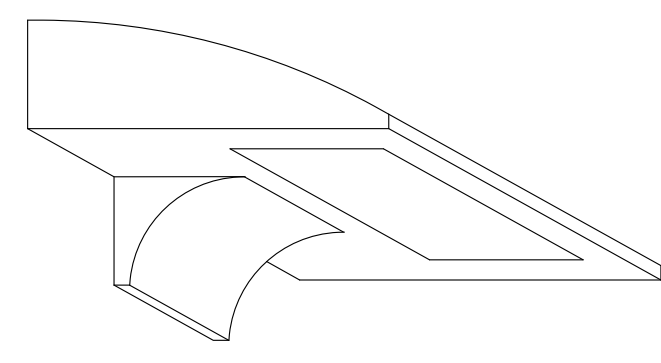


TYPICAL WALL PACK DETAIL
SCALE: NTS

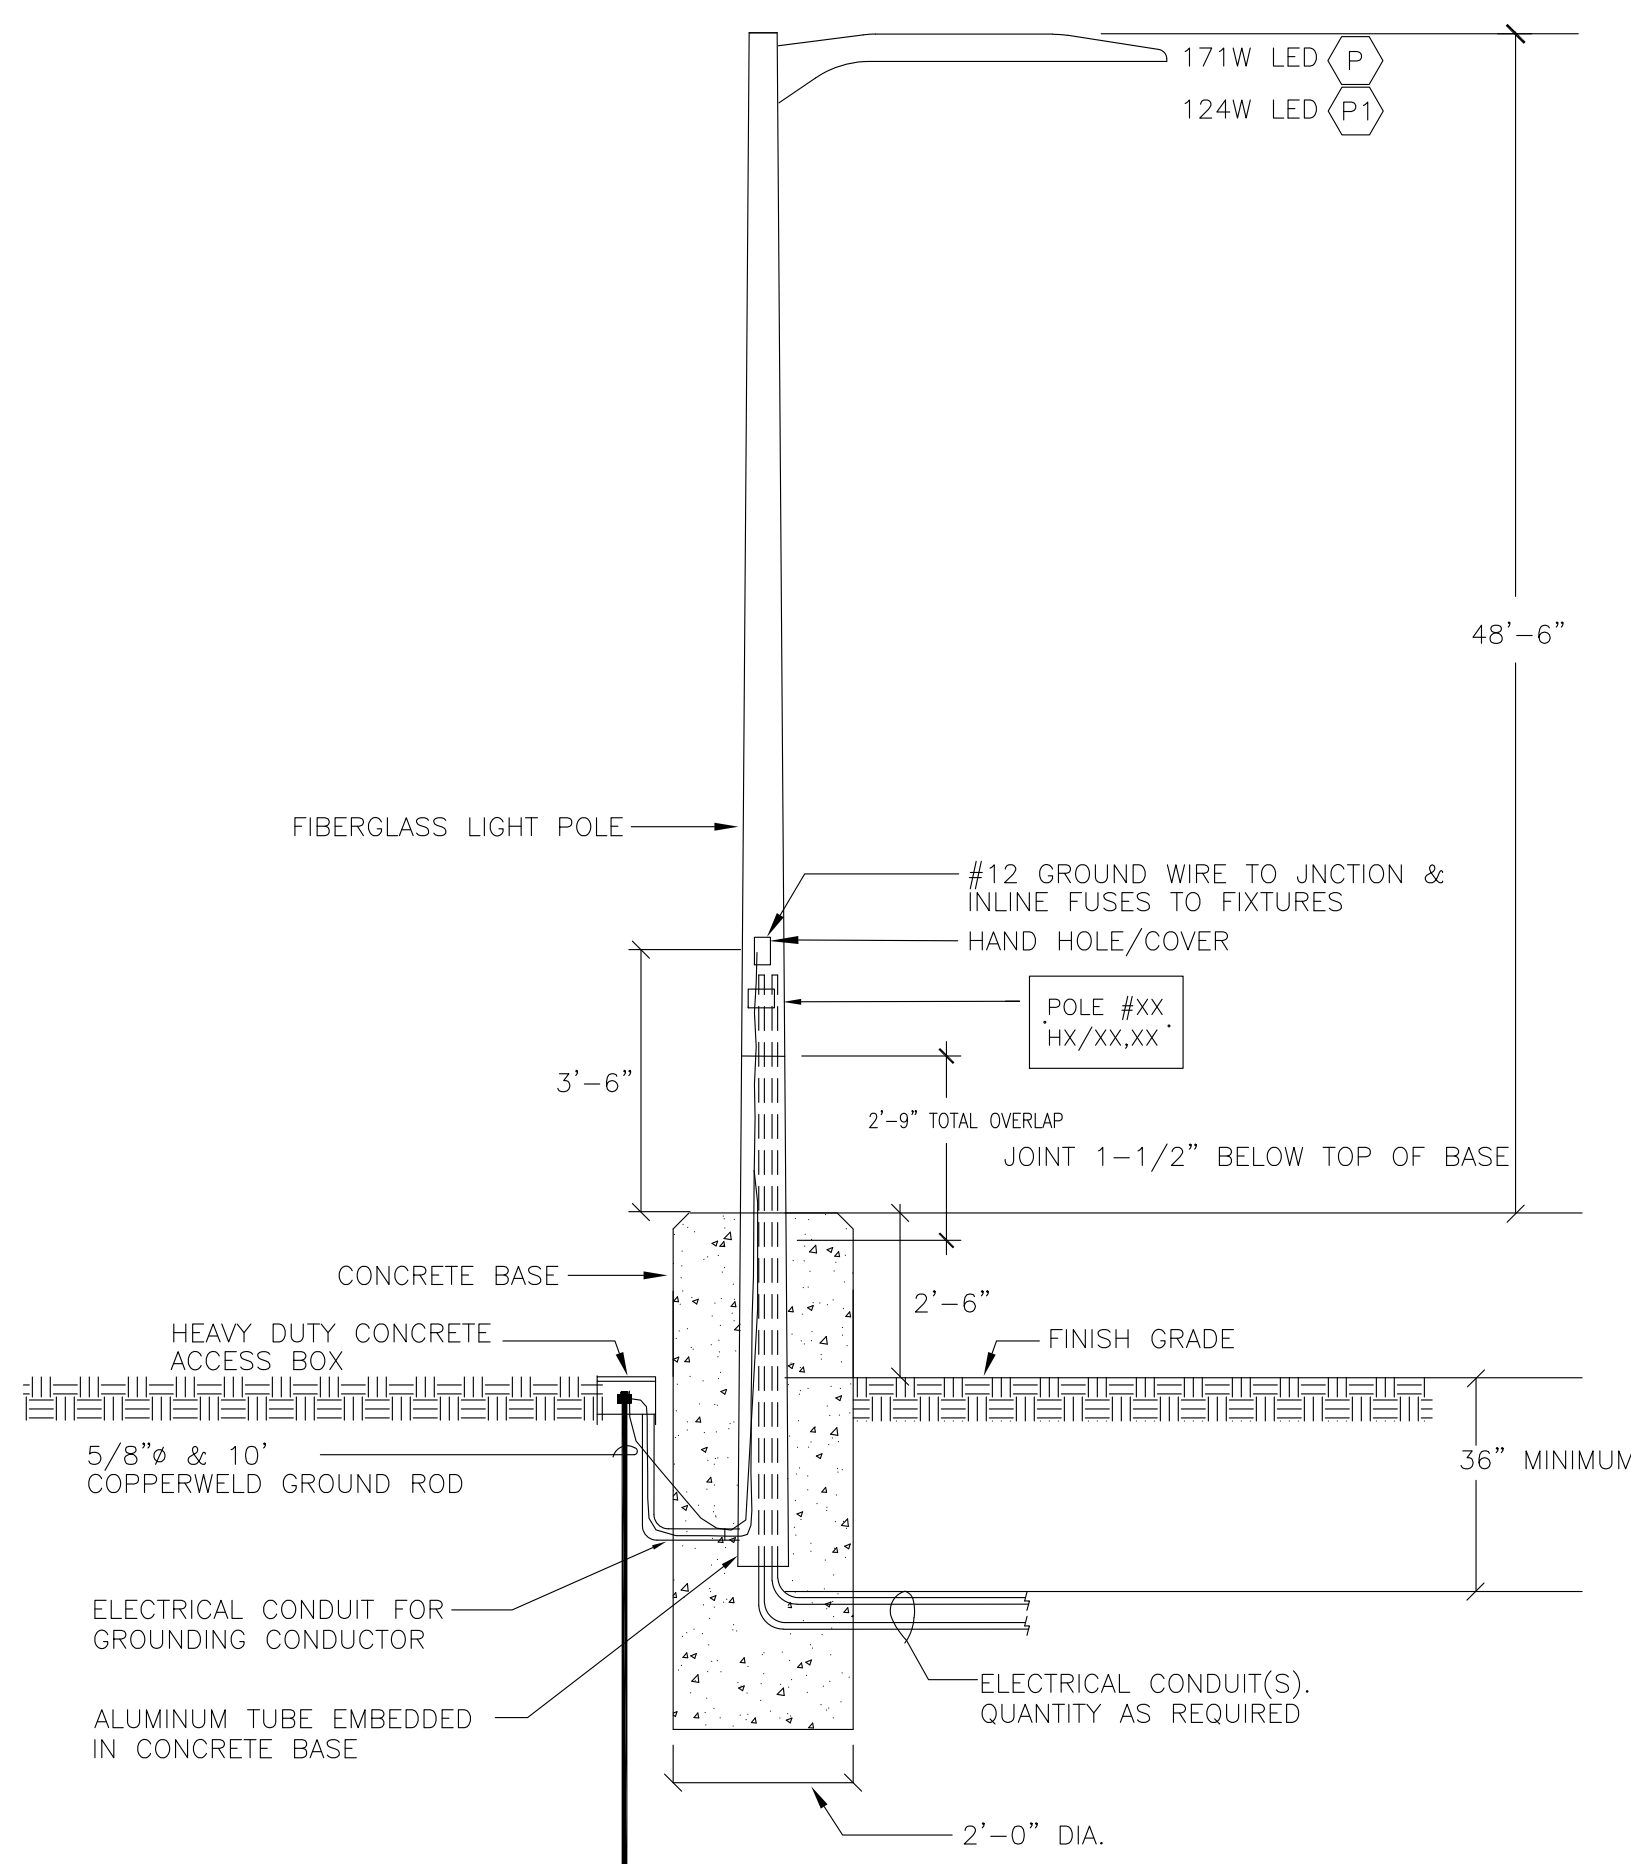

NOTE: PROVIDE CONCRETE J-BOX AS REQUIRED. THIS DETAIL IS FOR ELECTRICAL CONDUITS ROUTING ONLY. SEE STRUCTURAL DRAWINGS S0.2 FOR DETAILS.

POLE DETAIL
SCALE: NTS

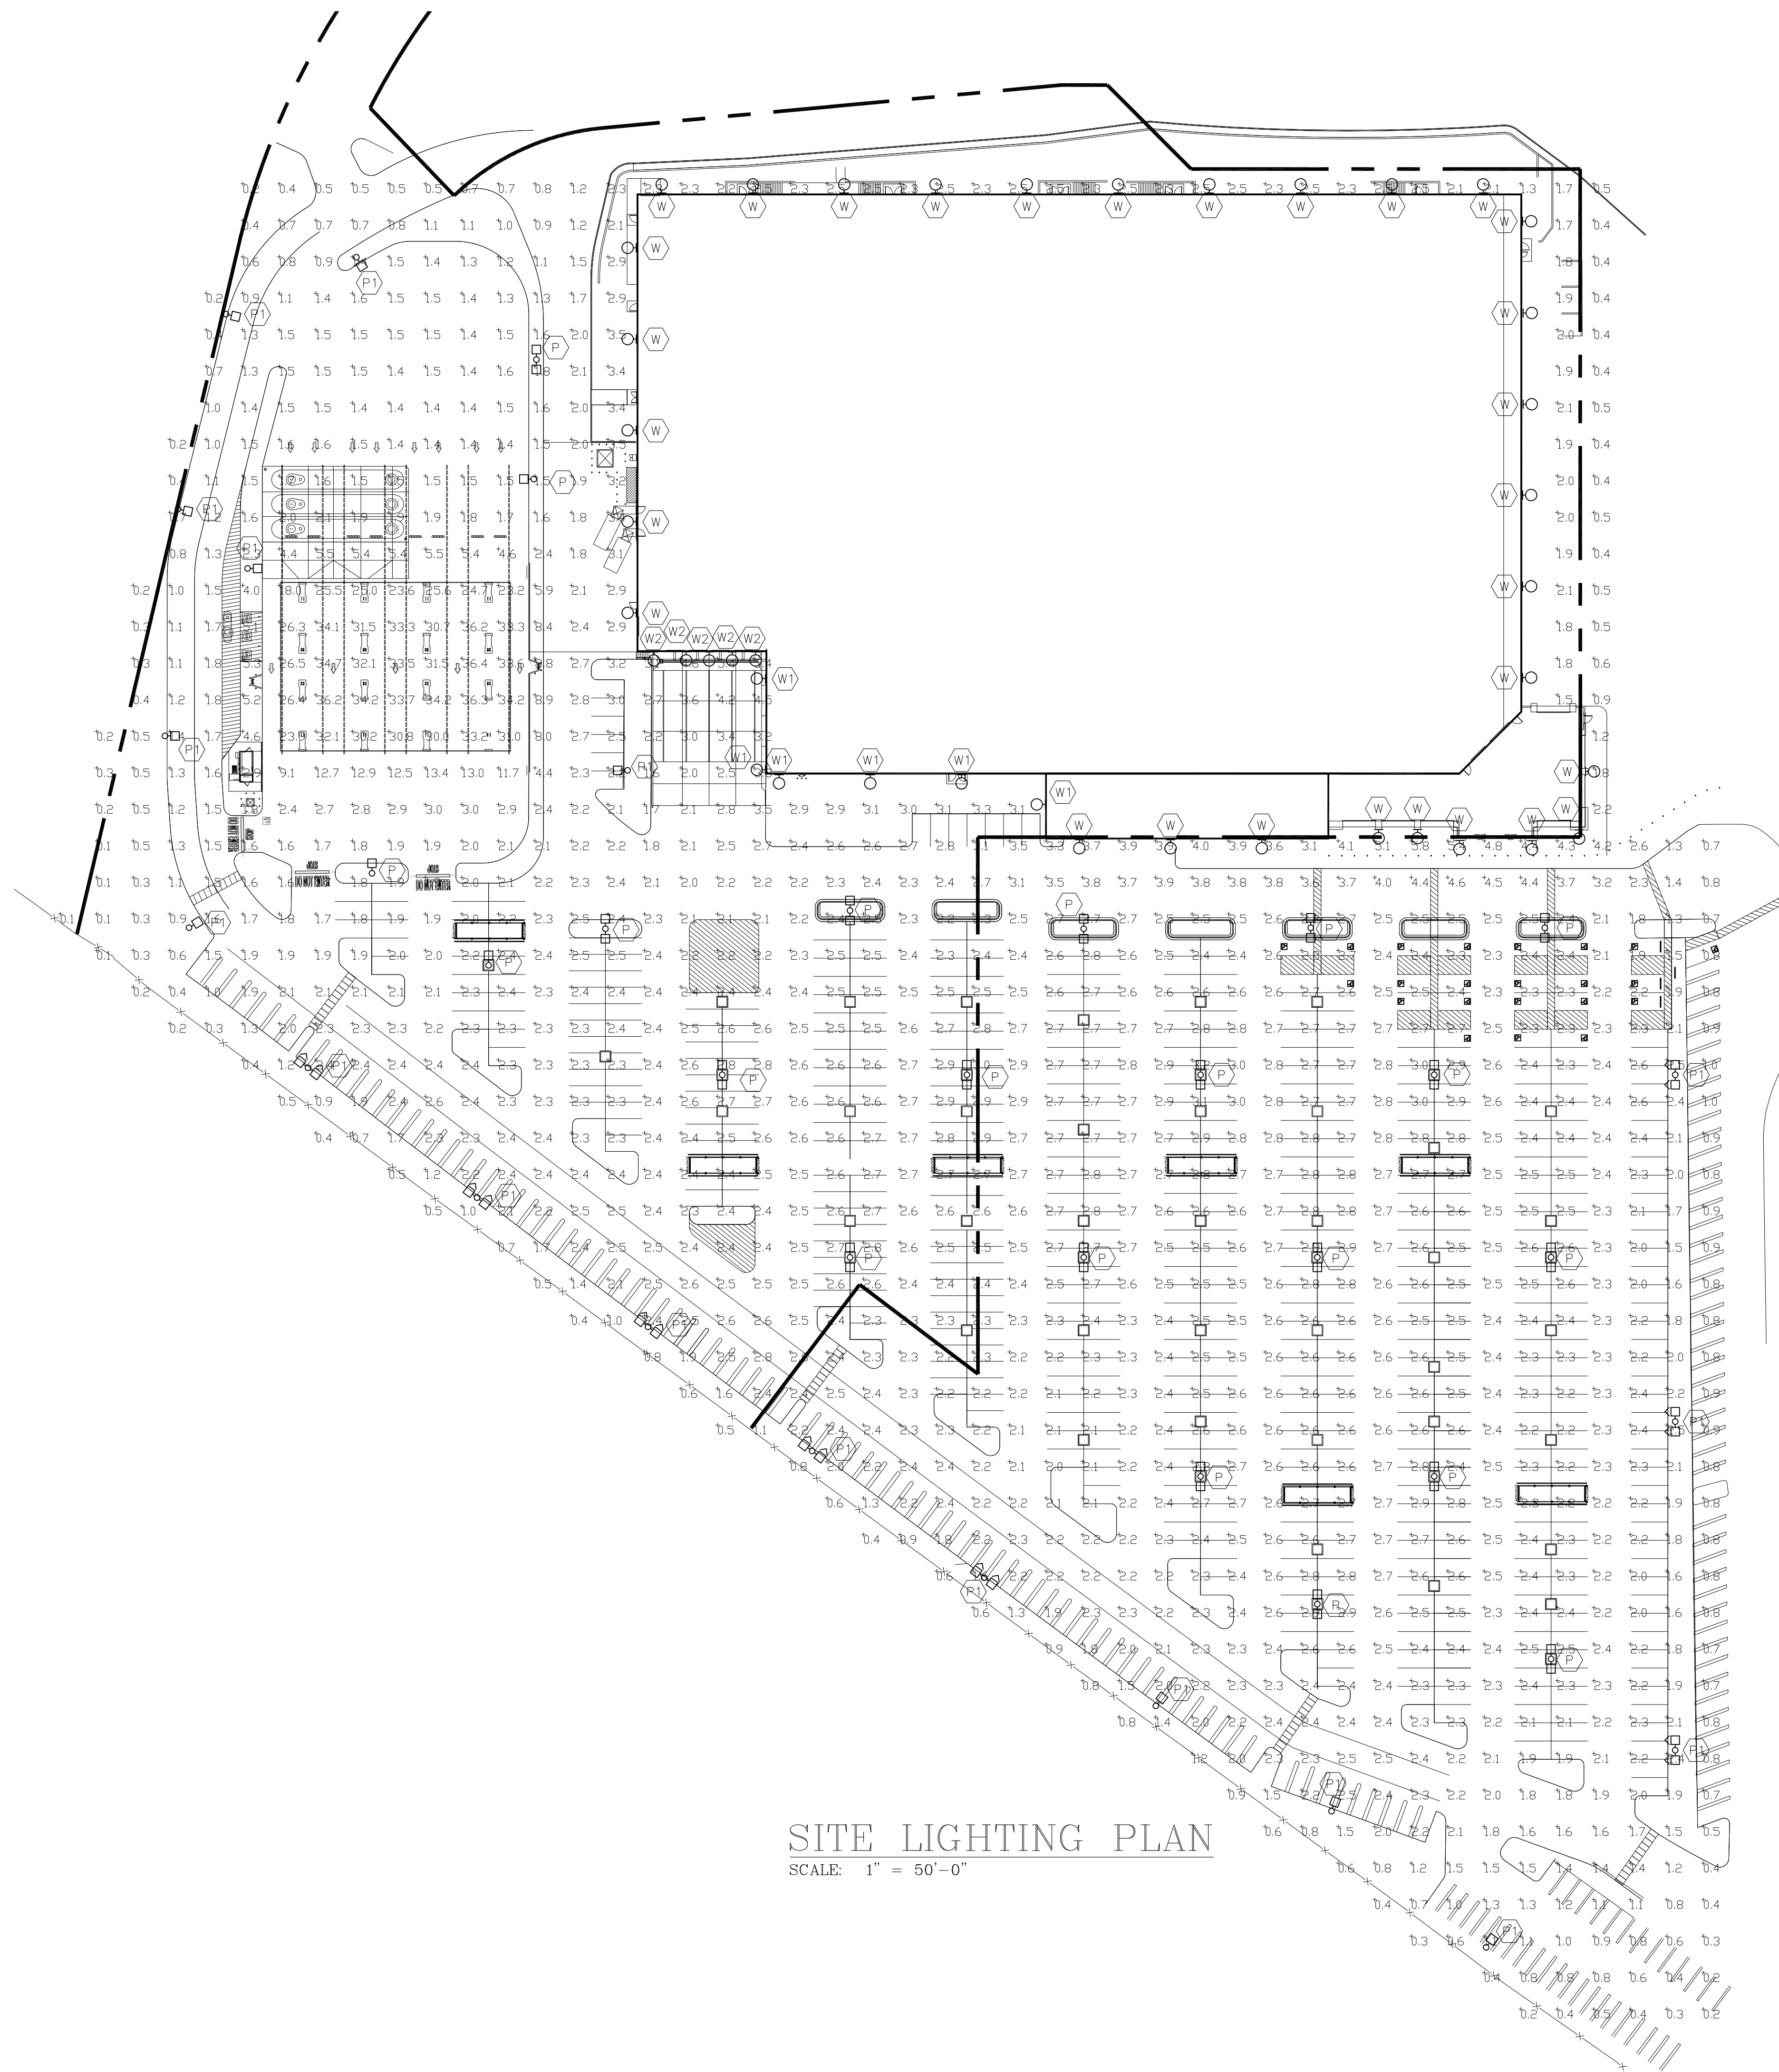


SITE LIGHTING PLAN
SCALE: 1" = 50'-0"

ISSUED FOR QA REVIEW, NOT FOR CONSTRUCTION

PROJECT NO: 22-215 ARCHITECT REFERENCE NO: 19-0135-01 DD PACKAGE T.B., Inc. 890 N. RIVERSIDE DRIVE SUITE #200 RENTON, WA 98057 PHONE: 425-970-3753 FAX: 425-970-3756 ESCONDIDO, CA

US PART OF THIS DOCUMENT MAY BE USED OR COPIED IN WHOLE OR IN PART WITHOUT THE PRIOR WRITTEN CONSENT OF T.B., INC.

CHECKED: JDM DRAWN: NV REVISION DATE: 04/29/22 ISSUE DATE: APRIL 2022

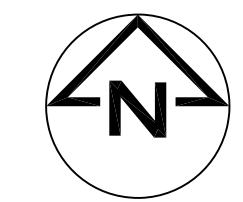


SE-1



DD PACKAGE

T.B., Inc.

890 N. RIVERSIDE DRIVE
SUITE #200
RENTON, WA 98057
PHONE: 425-970-3753
FAX: 425-970-3756

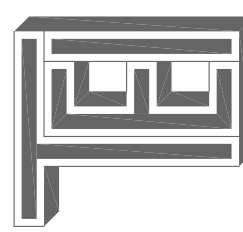

04/29/22 ISSUED FOR QA